


**2 TYPICAL WALL SECTION**  
SCALE: 3/4" = 1'-0"

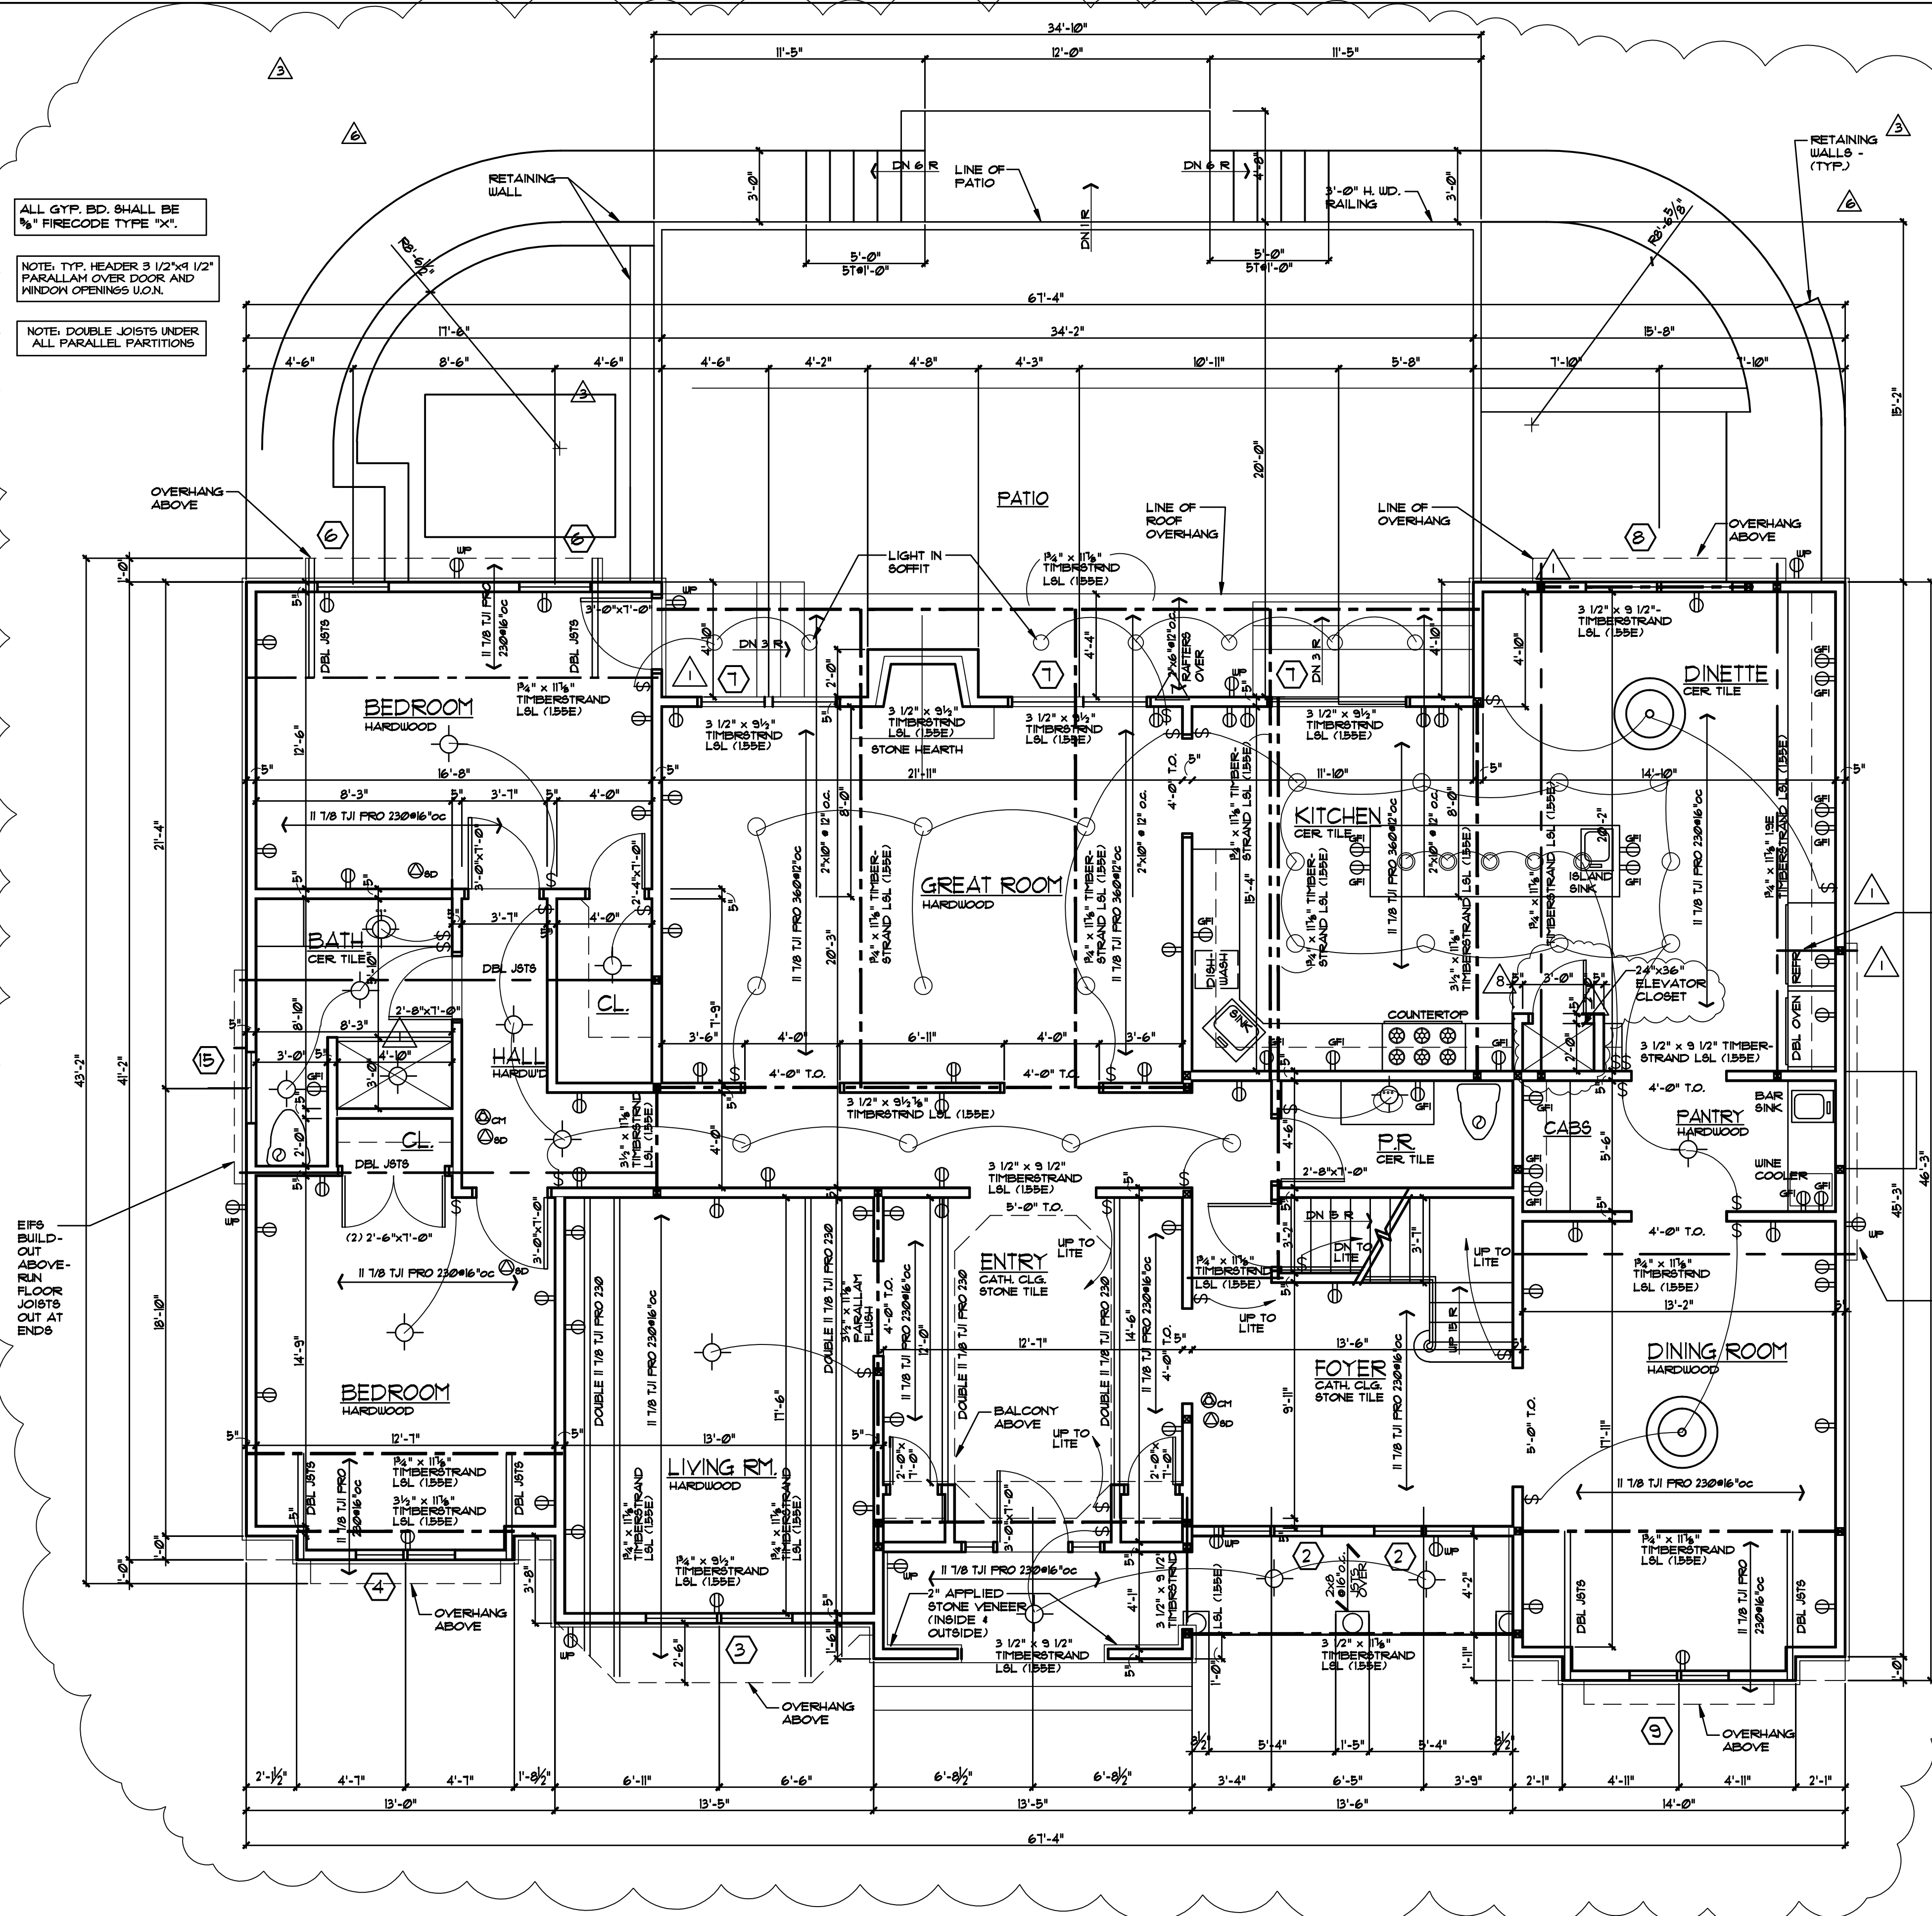

**FIRST FLOOR PLAN**  
SCALE: 1/4" = 1'-0"

- 10-14-10 ADDED DUMBWATER INFO
- 9-28-10 MODIFIED STRUCTURAL INFO,
- 9-16-10 MODIFIED DRIVE, WALKS, LOT COVERAGE
- 7-20-10 MISC. REVISIONS PER OWNER CORR. WALL, FRAMING, ETC.
- 6-24-10 MISC. REVISIONS PER OWNER BASEMENT, FRAMING, ETC.
- 6-15-10 MISC. REVISIONS PER OWNER PATIO, FRAMING, ETC.
- 6-2-10 MISCELLANEOUS REVISIONS
- 6-24-09 ISSUED FOR PERMIT

**HEINTZ & FIORE • LLC**  
ARCHITECTS • AIA

87 woodland road  
short hills • new jersey • 07078  
973-467-1240 fax 973-376-0963

**BRONSTEIN RESIDENCE**  
5 RICHARD DRIVE  
SHORT HILLS, NJ

drawing title:  
**FIRST FLOOR PLAN**  
PLUMBING RISER DIAGRAM

ROBERT B. HEINTZ • AIA  
architect : NJ - C 4352  
DONALD R. FIORE • AIA  
architect : NJ - A1 10410

job no. : 2916  
date : 6-24-09

scale : AS NOTED  
drawing : JSK

A-2