



**PLUMBING RISER DIAGRAM**  
NOT TO SCALE

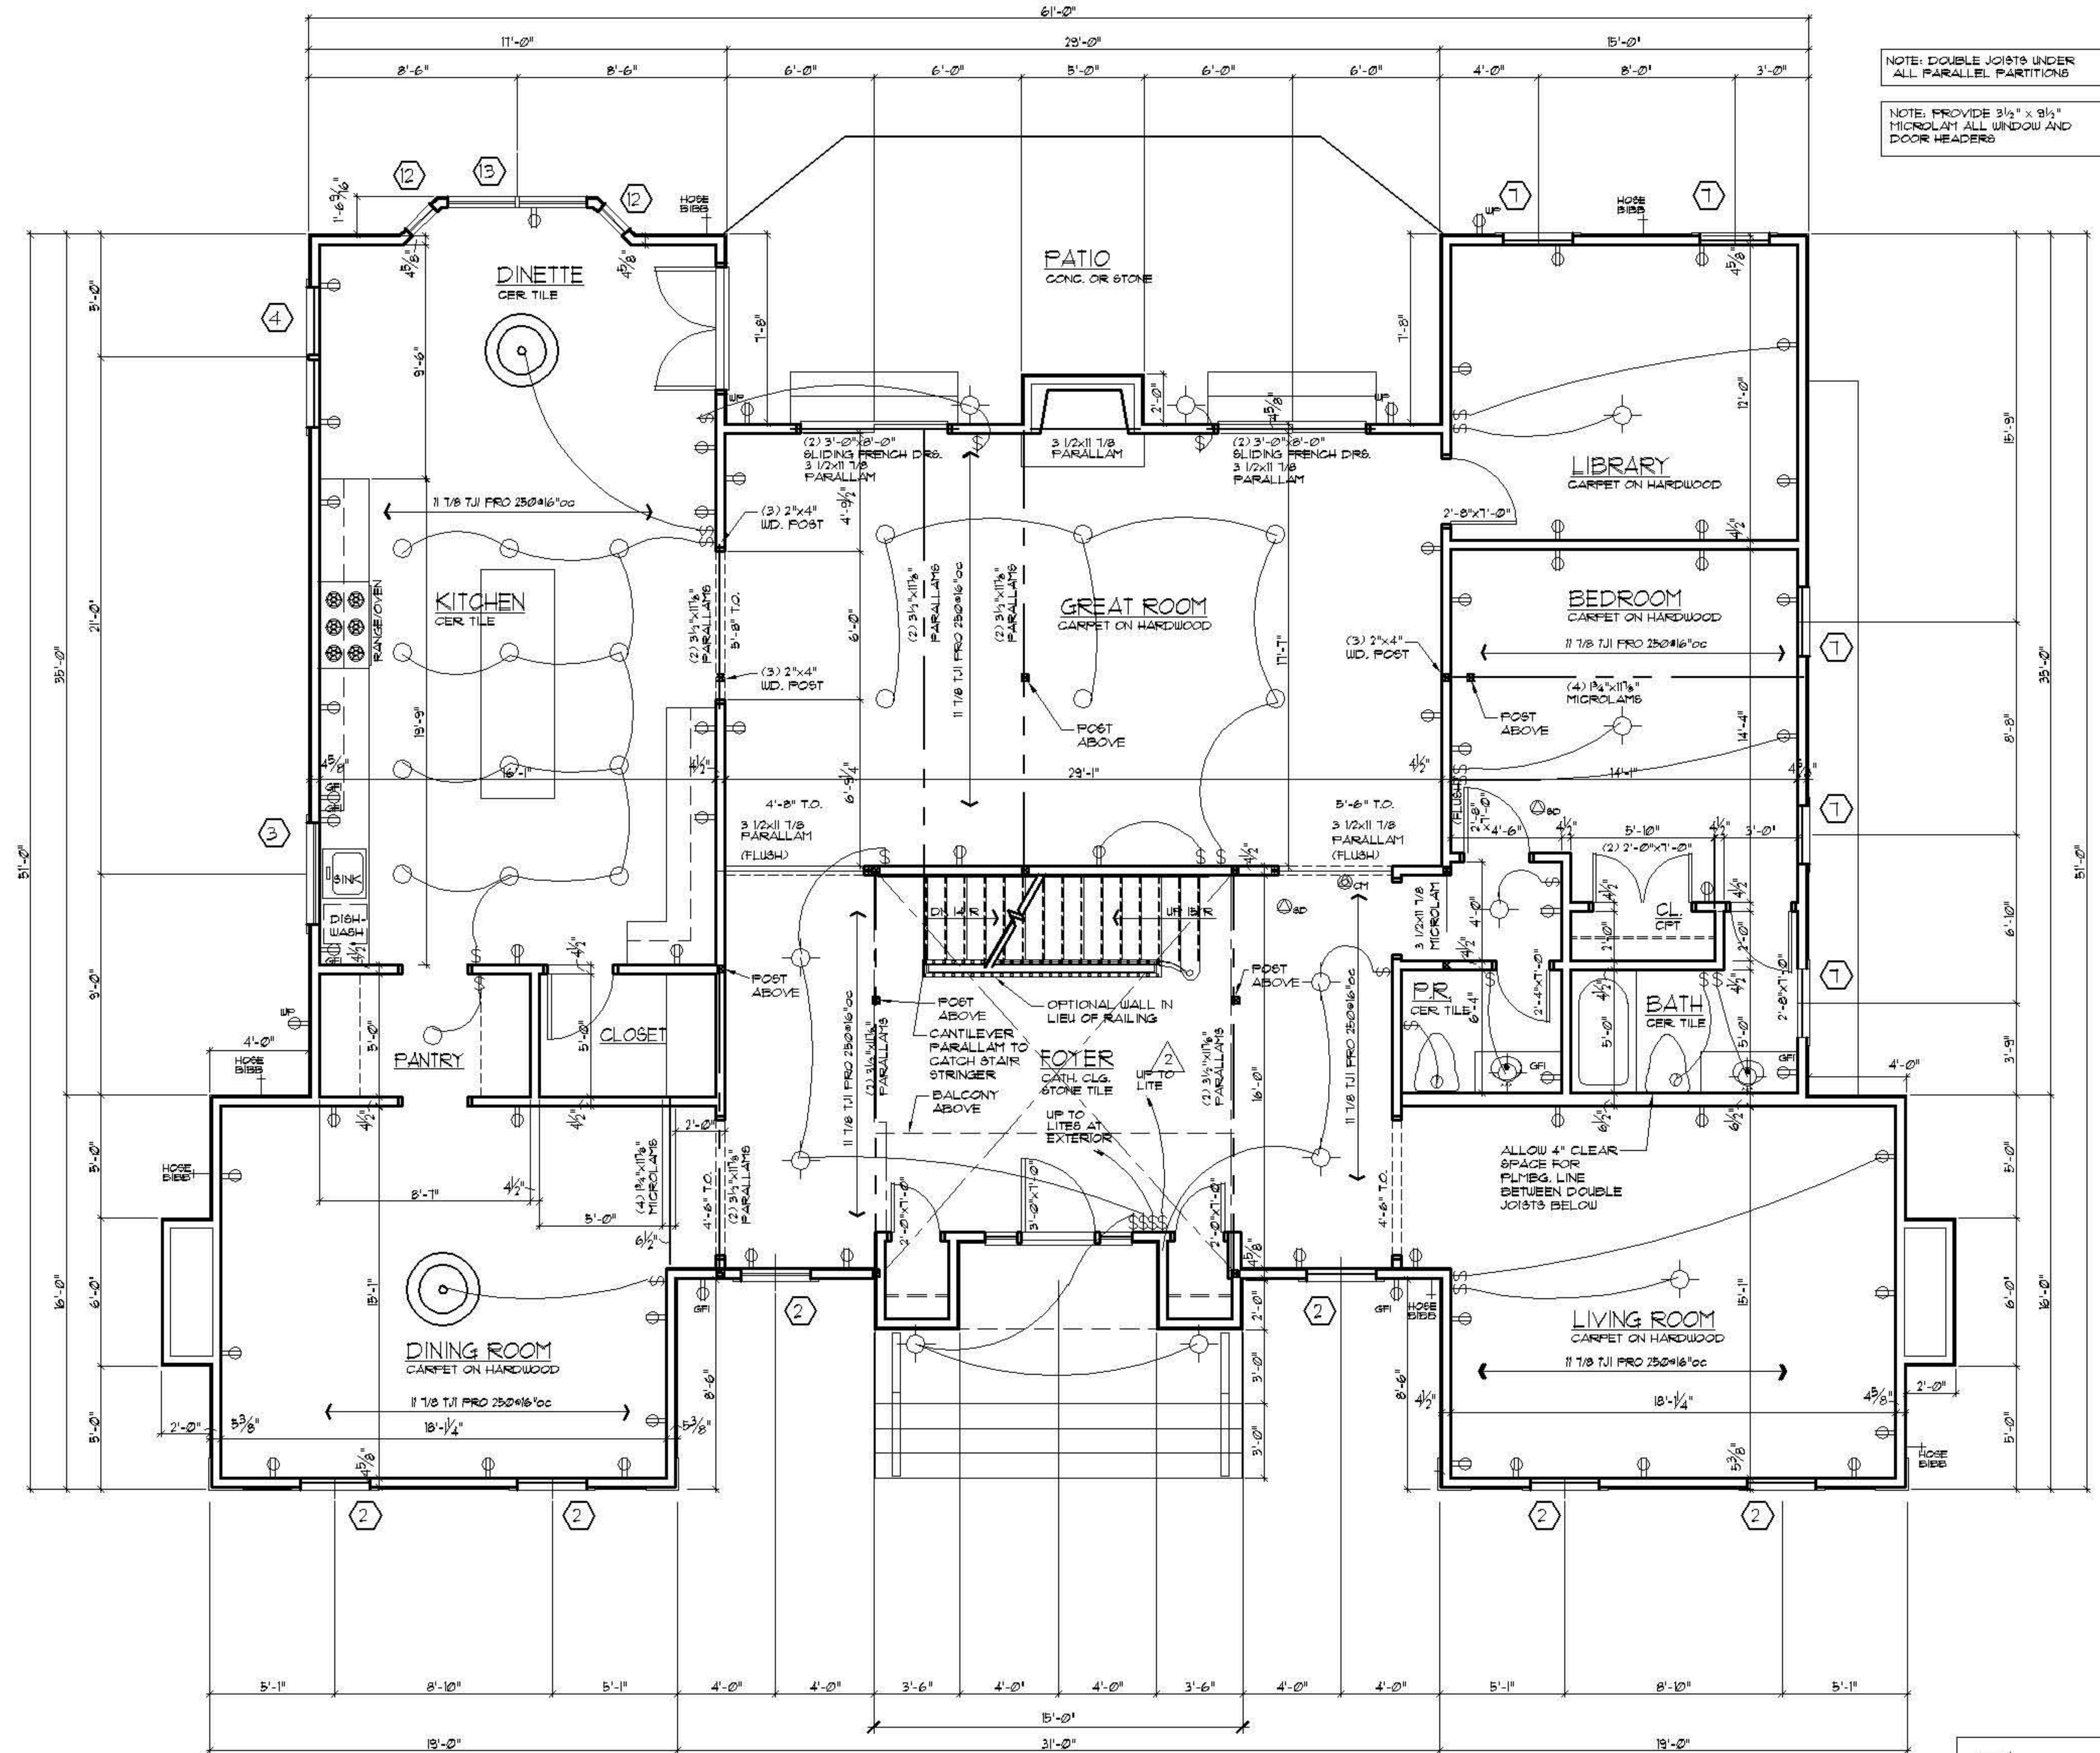

NOTE: DOUBLE JOISTS UNDER ALL PARALLEL PARTITIONS  
NOTE: PROVIDE 3/4\" x 9/16\" MICROLAM ALL WINDOW AND DOOR HEADERS

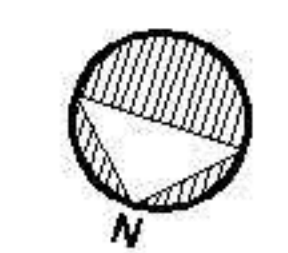

**FIRST FLOOR PLAN**

SCALE: 1/4\" = 1'-0\"

**HEINTZ & FIORE • LLC**  
ARCHITECTS • AIA  
87 woodland road  
short hills • new jersey • 07078  
973-467-1240 fax 973-376-0963

BRONSTEIN RESIDENCE  
142 FAIRFIELD DRIVE  
SHORT HILLS, NJ

drawing title:  
**FIRST FLOOR PLAN  
PLUMBING RISER DIAGRAM**

ROBERT B. HEINTZ • AIA  
architect : NJ - C 4392  
planner : NJ - U 01553  
DONALD R. FIORE • AIA  
architect : NJ - AI 10410

job no. : 2822 scale : AS NOTED  
date : 03-04-08 drawn by : JSK

drawing :  
**A-2**