


**REAR ELEVATION**

SCALE : 1/4" = 1'-0"

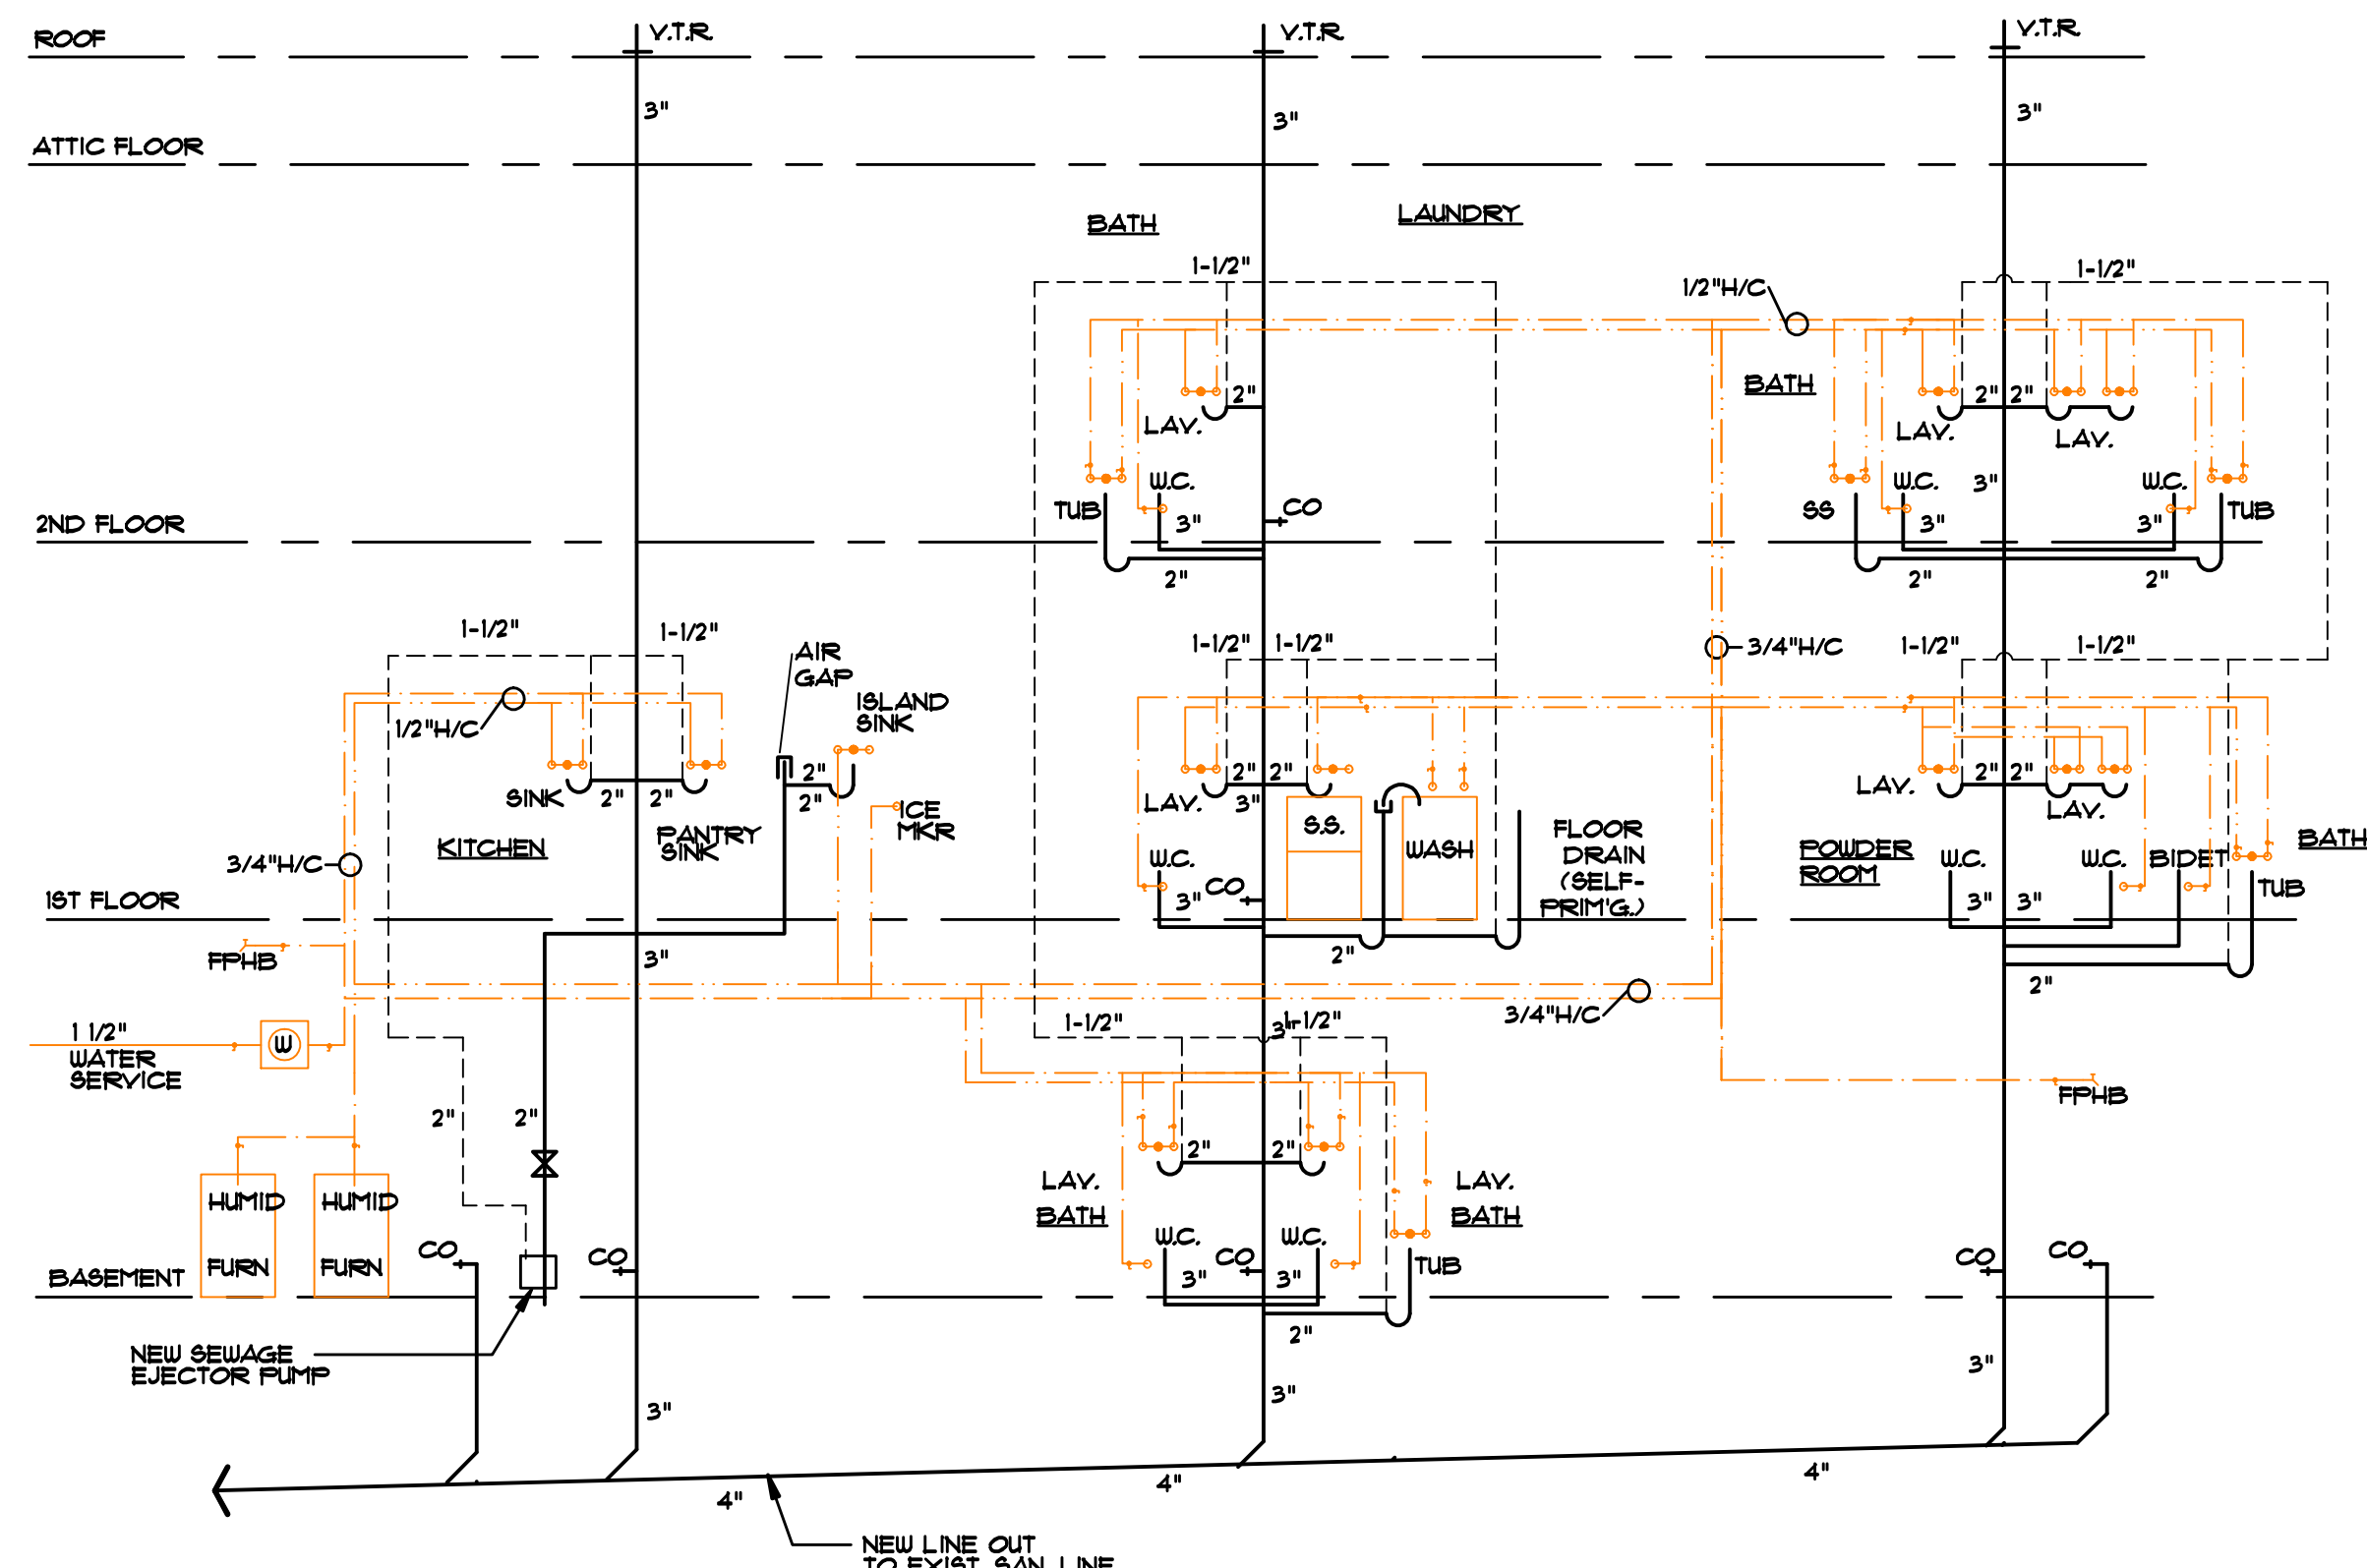

**PLUMBING RISER DIAGRAM**

NOT TO SCALE WITH WATER RISER INFO

NOTE:  
ALL WATER LINES TO BATH GROUPS = 3/4"  
ALL WATER LINES TO INDIV. FIXTURES = 1/2"

6/1/09 MODIFIED GRADES FOR BLDG HEIGHT CLARIFICATION  
5-6-09 ISSUED FOR PERMIT

**HEINTZ & FIORE • LLC**  
ARCHITECTS • AIA  
87 woodland road  
short hills • new jersey • 07078  
973-467-1240 fax 973-376-0963

RESIDENCE for MR. & MRS. EDWARD RUMMEL  
260 HARTSHORN DRIVE  
SHORT HILLS, NJ

drawing title:  
**REAR ELEVATION  
PLUMBING RISER DIAGRAM**

ROBERT B. HEINTZ • AIA  
architect : NJ - C 4352  
DONALD R. FIORE • AIA  
architect : NJ - AT 10410

job no. : 2917  
date : 5-6-09  
scale : AS NOTED  
drawn by : JSK

drawing :  
**A-6**