


ROOF PLAN
SCALE: 1/4" = 1'-0"

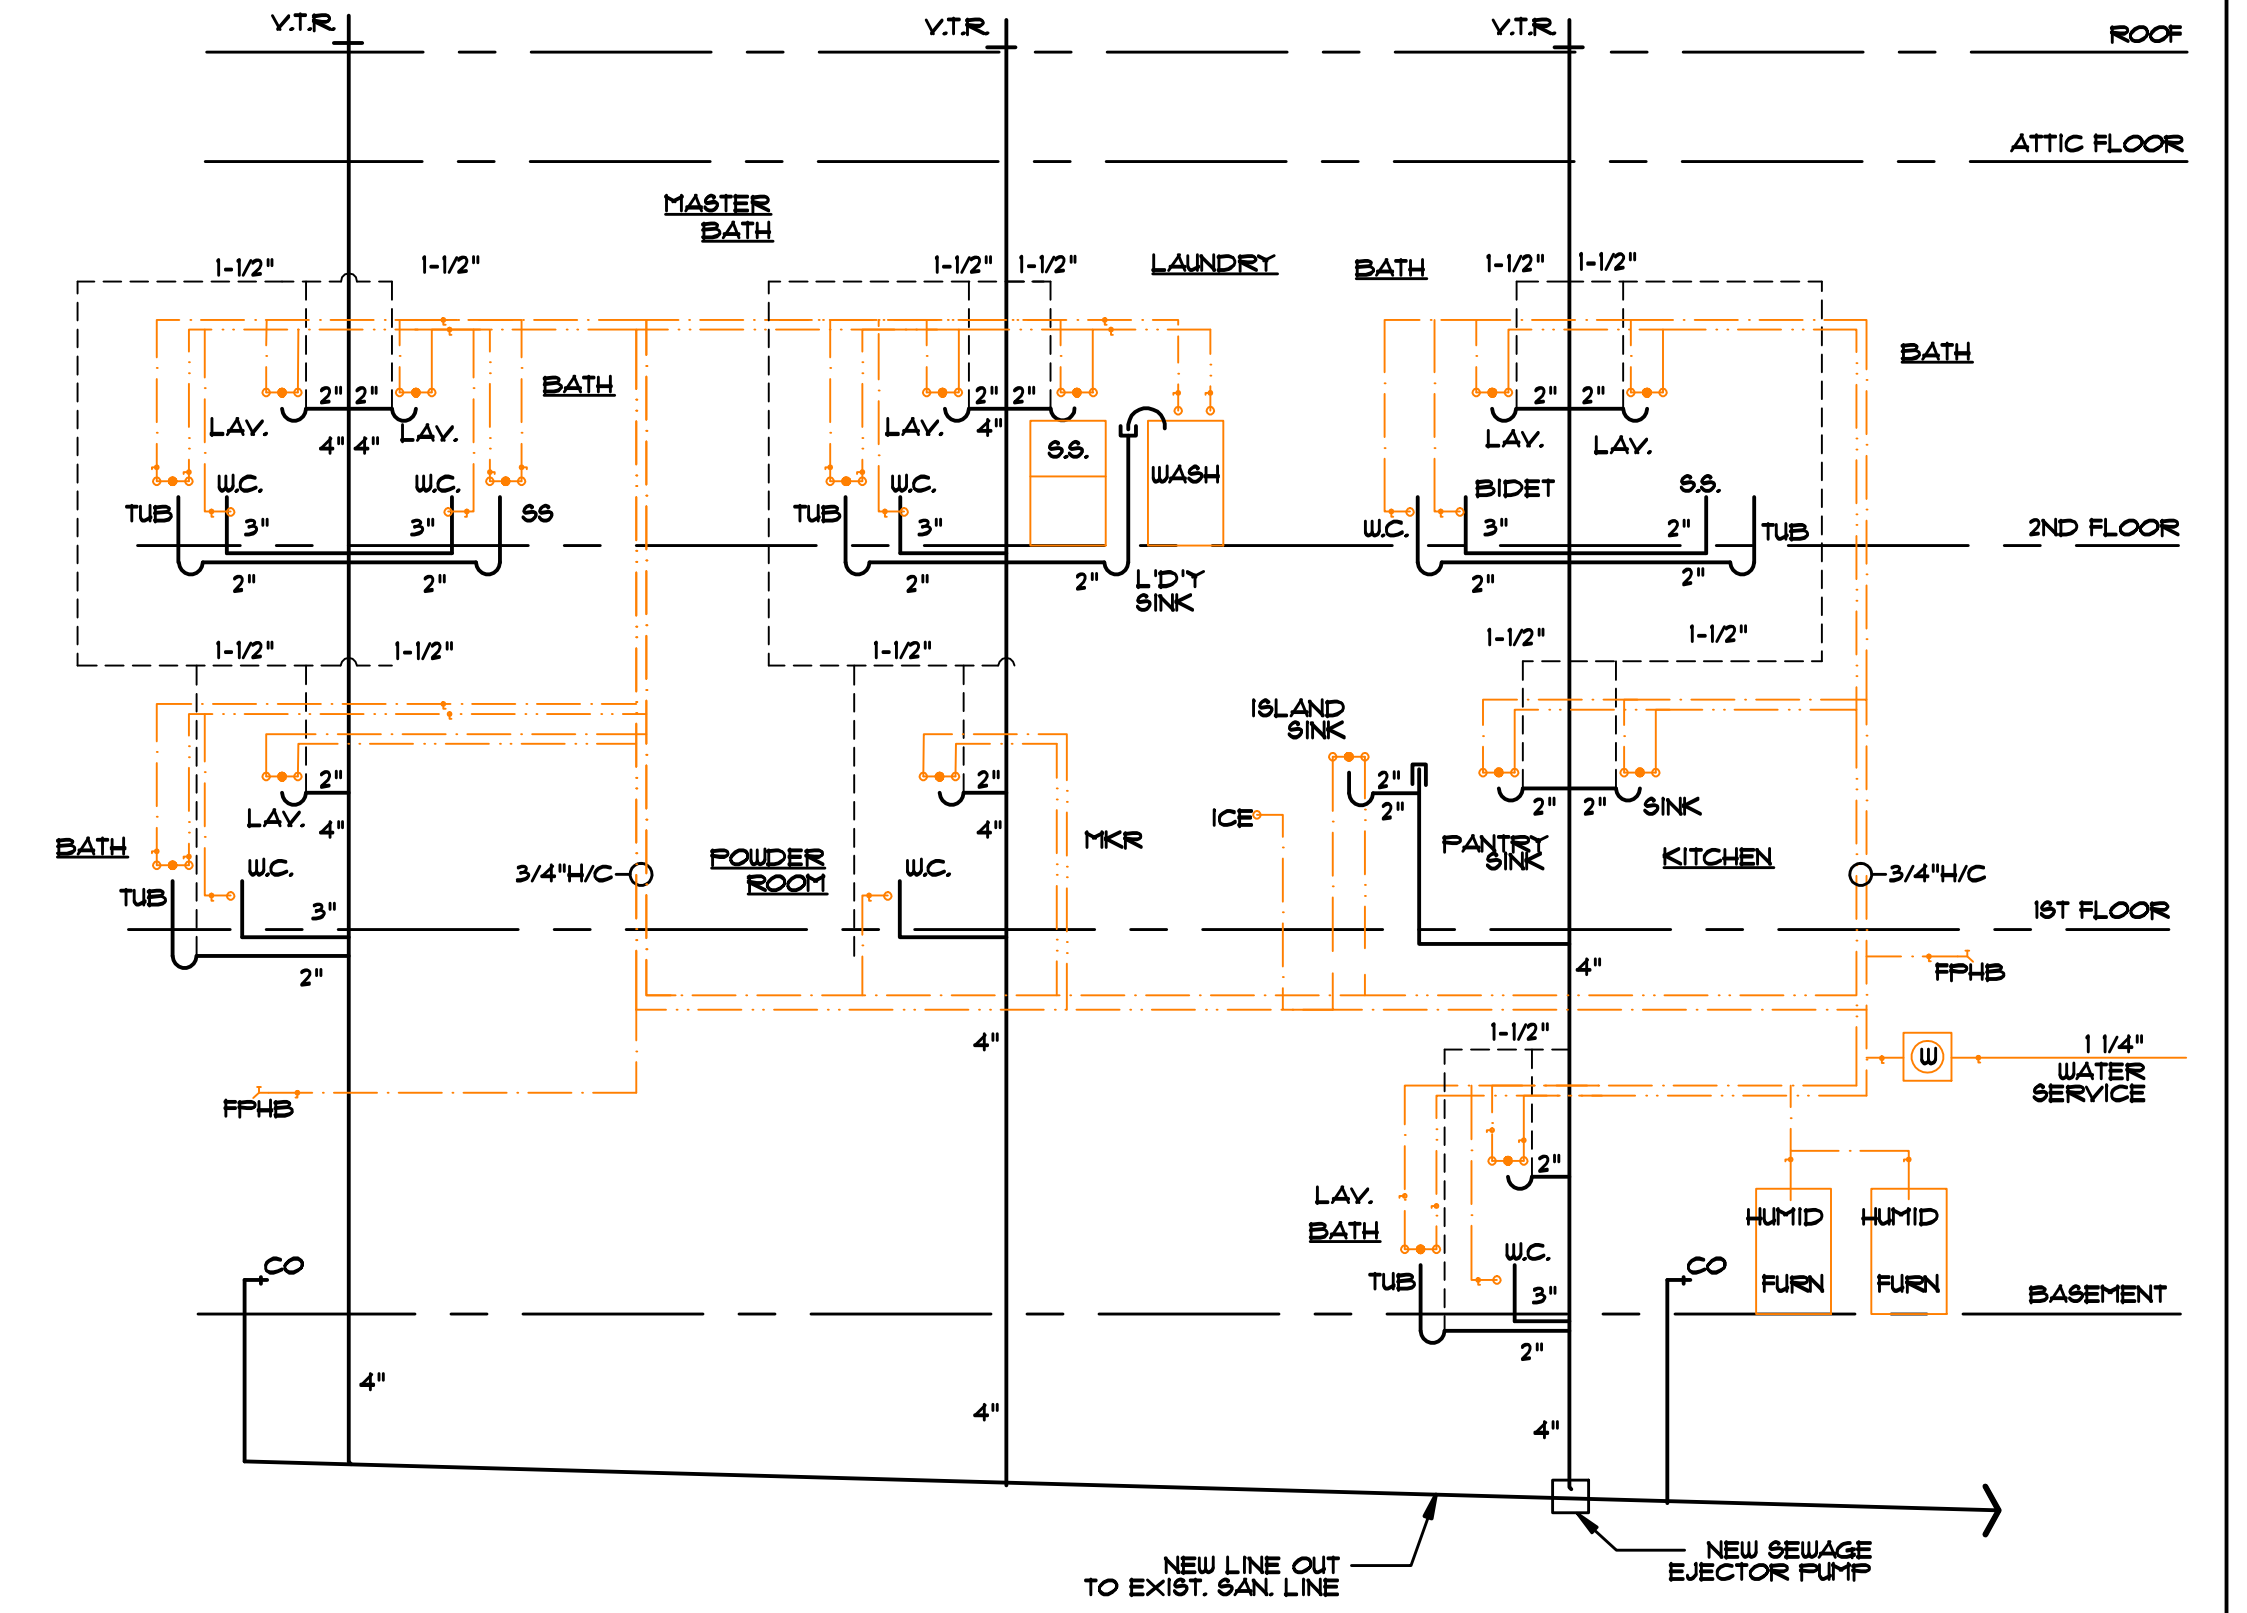

WATER RISER DIAGRAM
NOT TO SCALE

- △ 6-24-10 MISC. REVISIONS PER OWNER BASEMENT, FRAMING, ETC.
- △ 3 6-15-10 MISC. REVISIONS PER OWNER PATIO, FRAMING, ETC.
- △ 1 6-2-10 MISCELLANEOUS REVISIONS
- 6-24-09 ISSUED FOR PERMIT

HEINTZ & FIORE • LLC	
ARCHITECTS • AIA	
87 woodland road short hills • new jersey • 07078 973-467-1240 fax 973-376-0963	
BRONSTEIN RESIDENCE 5 RICHARD DRIVE SHORT HILLS, NJ	
drawing title: ROOF PLAN PLUMBING RISER DIAGRAM	
job no.: 2916 date: 6-24-09	scale: AS NOTED drawn by: JSK
drawing: A-7	