
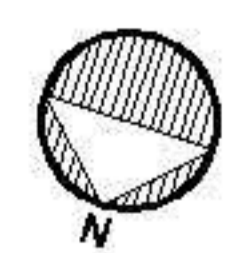


**PLUMBING RISER DIAGRAM**  
NOT TO SCALE

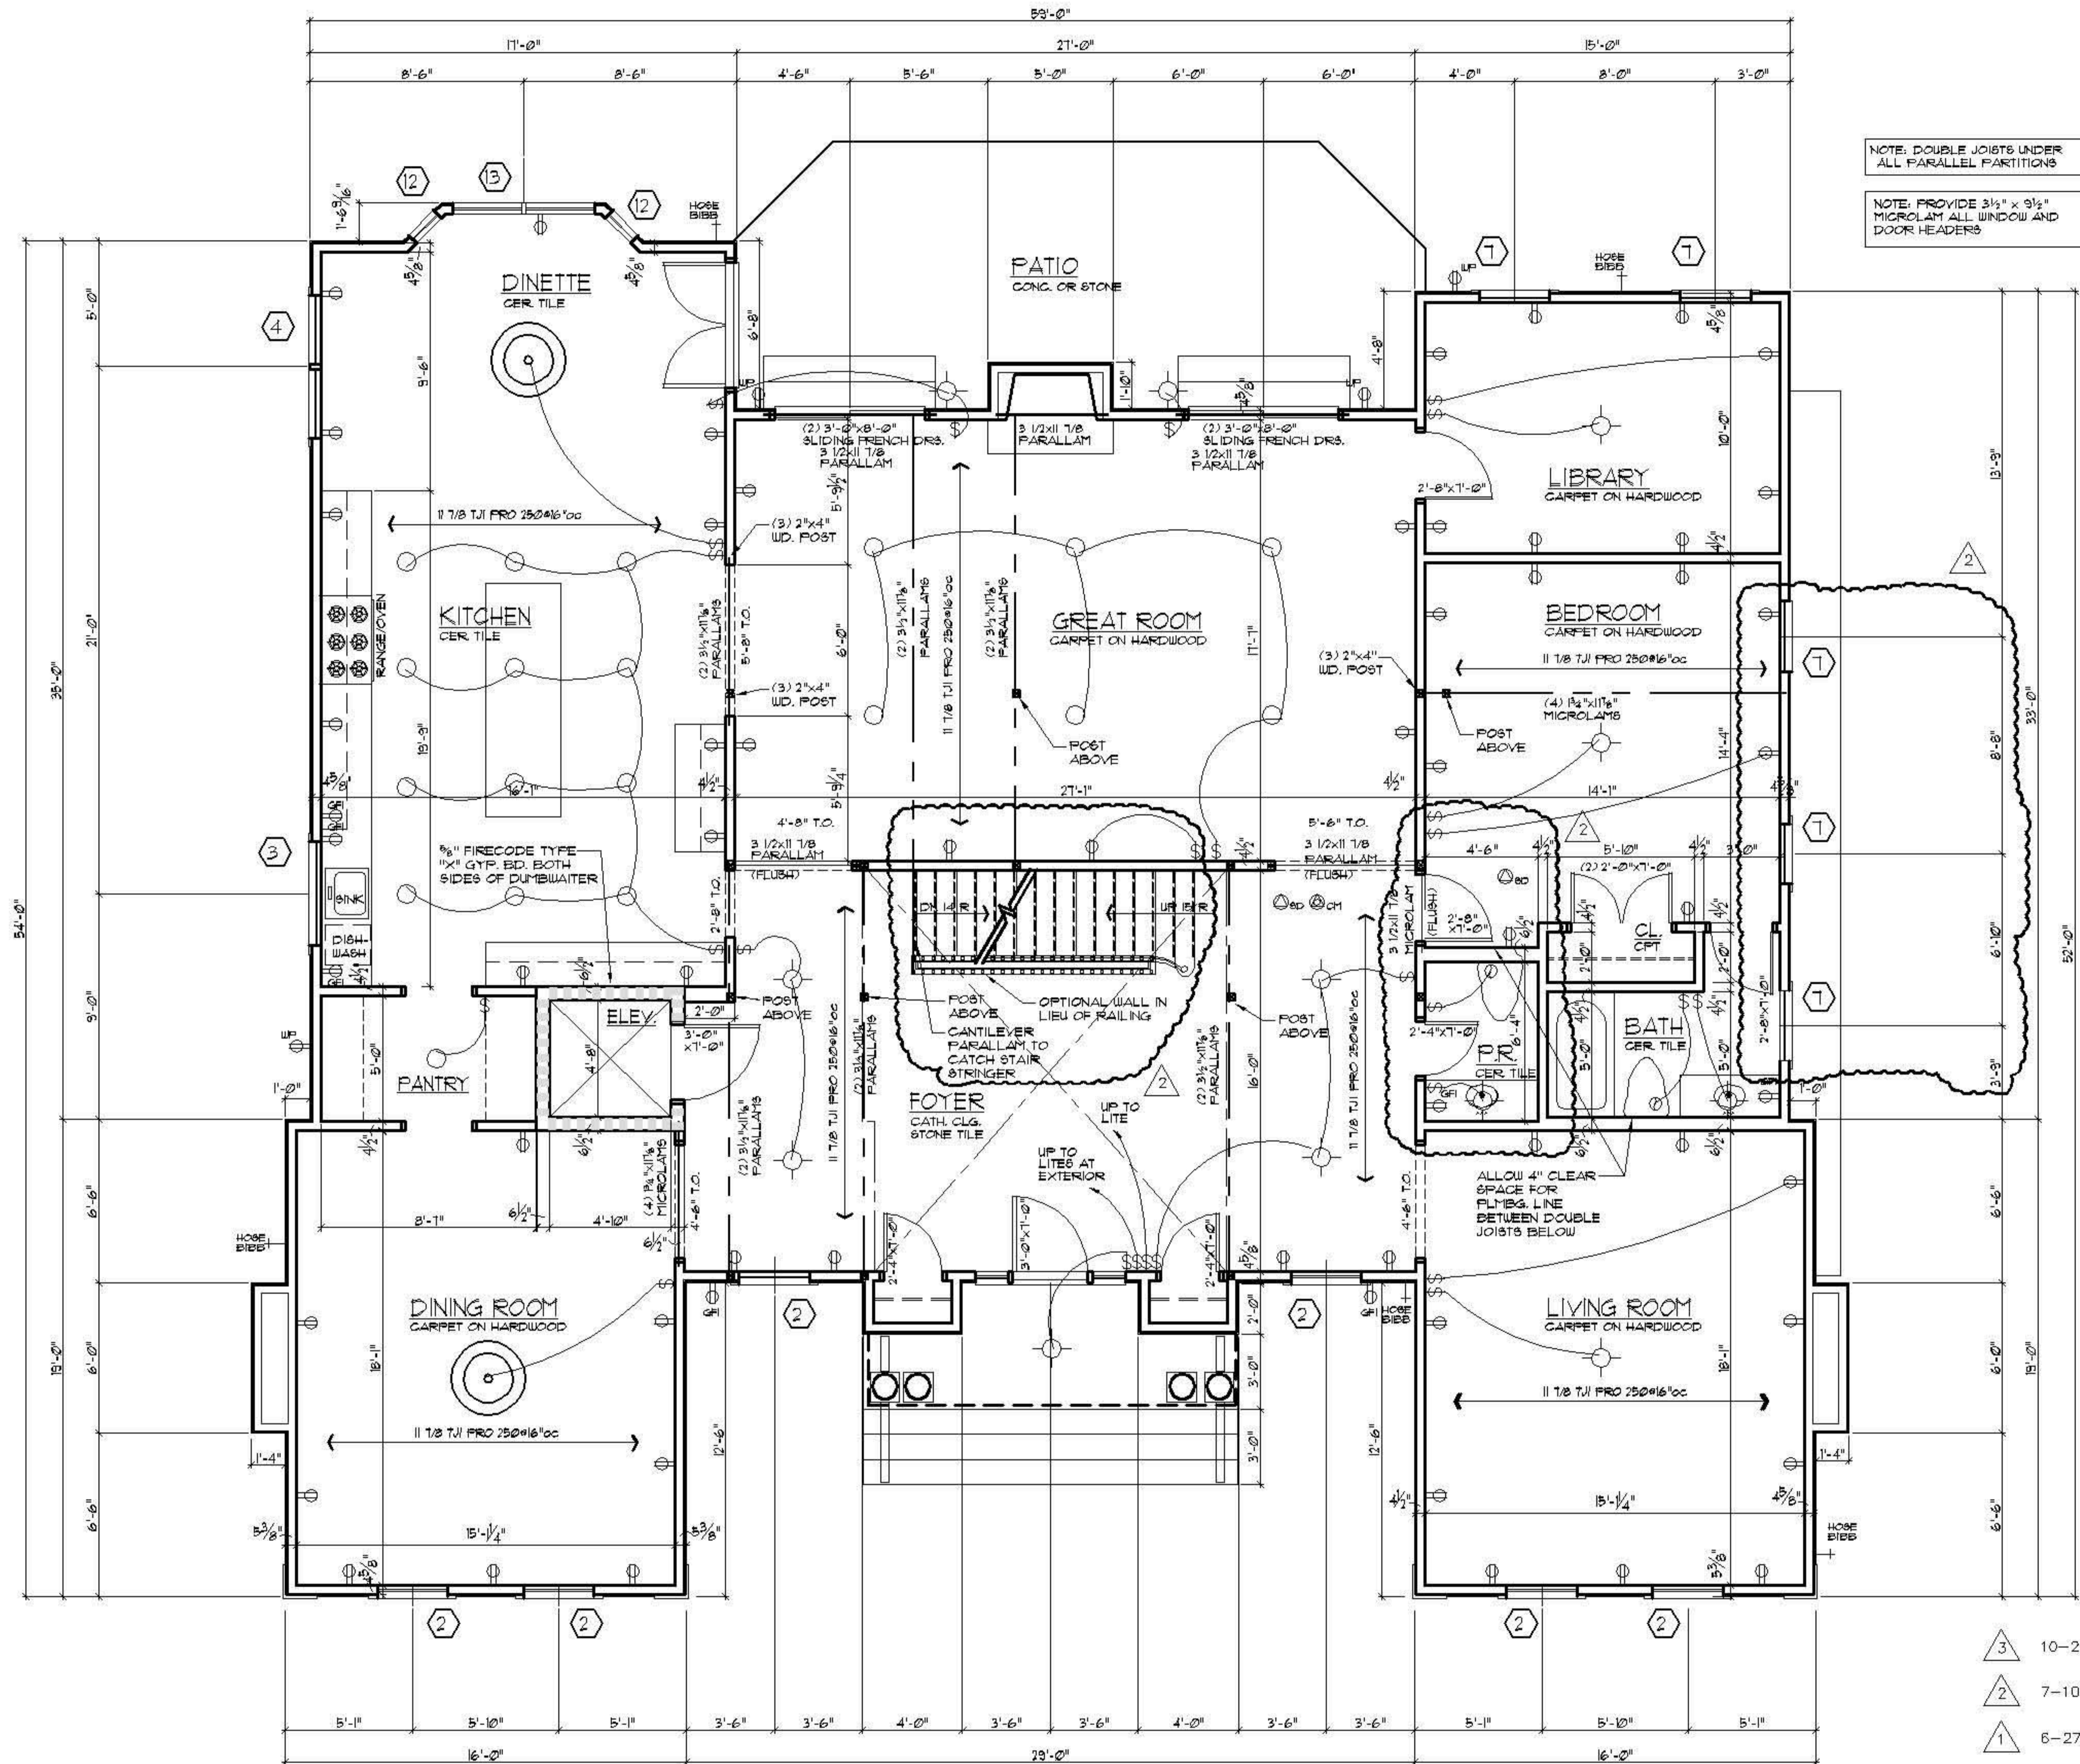

**FIRST FLOOR PLAN**

SCALE: 1/4" = 1'-0"

- 3 10-23-06 MODIFIED PLUMBING RISER DIAGRAM
- 2 7-10-06 MISCELLANEOUS REVISIONS PER OWNER
- 1 6-27-06 MISCELLANEOUS REVISIONS MODIFIED RISER DIAGRAM

**HEINTZ & FIORE • LLC**  
ARCHITECTS • AIA  
87 woodland road  
short hills • new jersey • 07078  
973-467-1240 fax 973-376-0963

BRONSTEIN RESIDENCE  
42 TROY DRIVE  
SHORT HILLS, NJ

drawing title:  
**FIRST FLOOR PLAN  
PLUMBING RISER DIAGRAM**

job no.: 2612 scale: AS NOTED  
date: 08-12-08 drawn by: JSK/EF

ROBERT B. HEINTZ • AIA  
architect: NJ - C 4392  
planner: NJ - U 01553  
DONALD R. FIORE • AIA  
architect: NJ - AI 10410

drawing:  
**A-2**