


BASEMENT FLOOR PLAN
SCALE: 1/4"=1'-0"

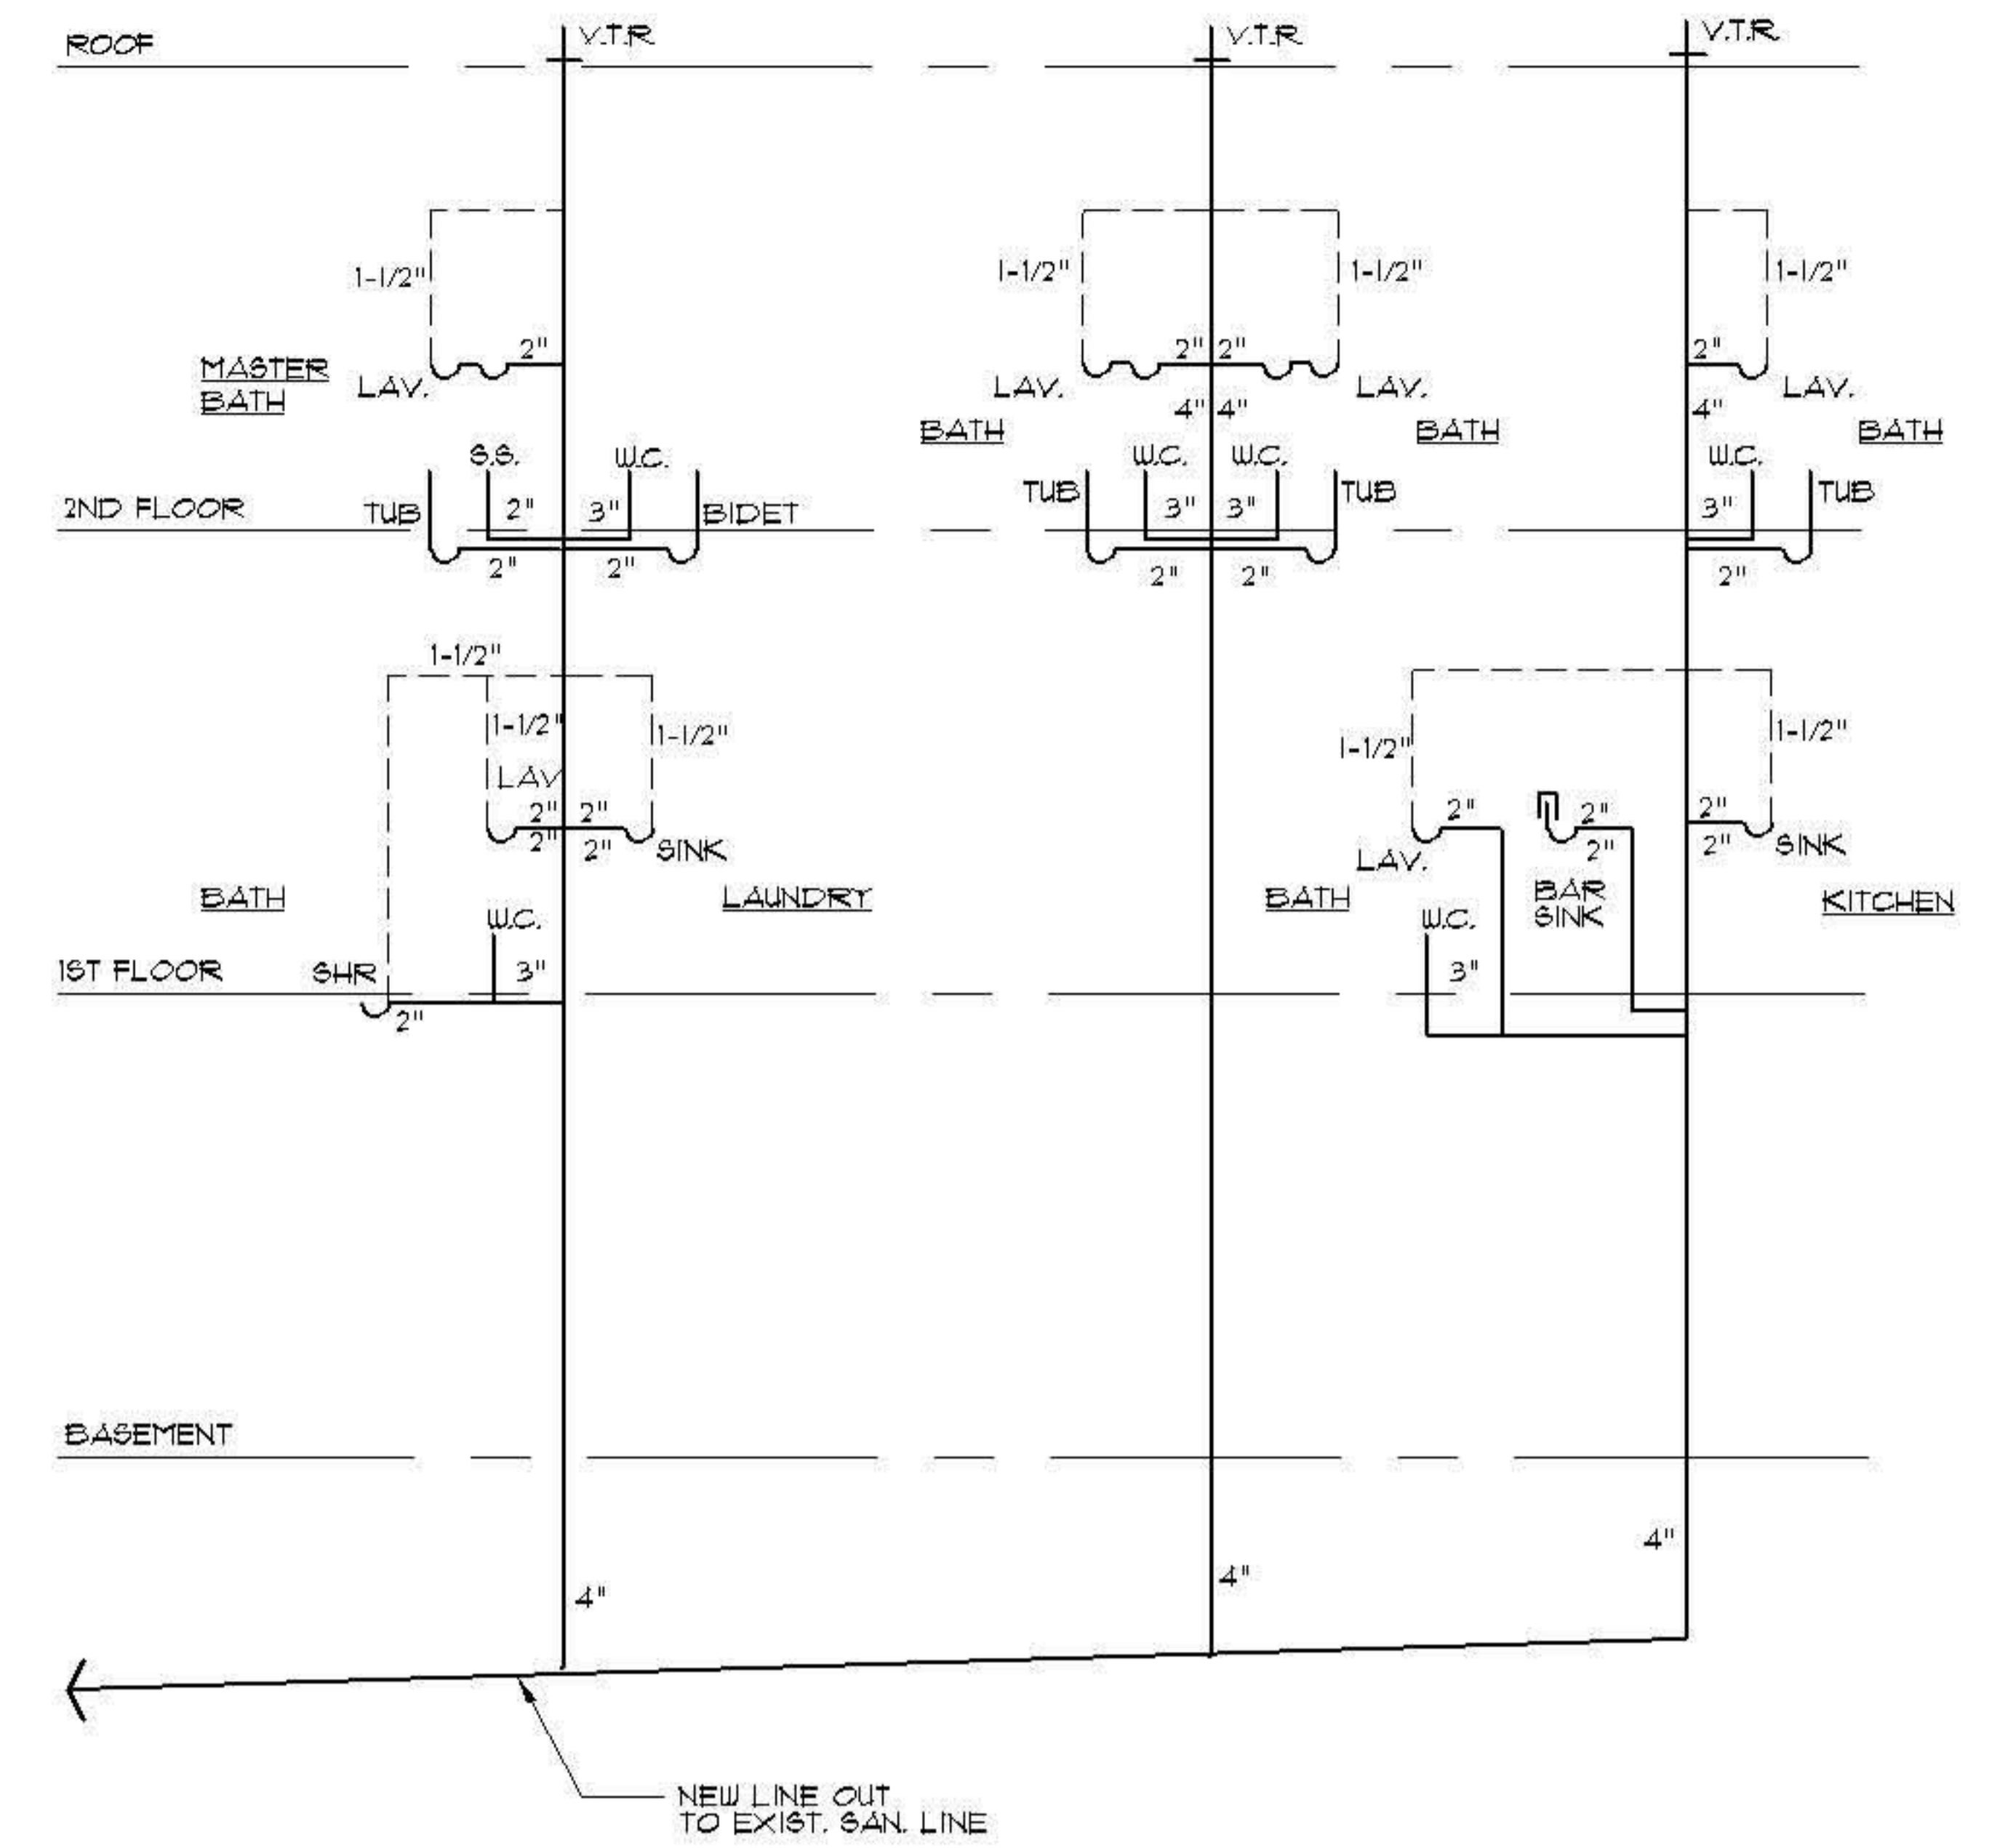

PLUMBING RISER DIAGRAM
NO SCALE

LEGEND	
	CONCRETE BLOCK WALL - SEE PLAN FOR WIDTH
	NEW CONSTRUCTION - 2"x4" WOOD STUDS AT 16" O.C. w/ 1/2" GYF. BD. OVER - PROVIDE R-13 INSUL. AT PERIMETER WALLS, SOUND ATTEN. INSUL. AT BATHROOMS, FOYER ROOMS, GARAGES, AND MASTER BEDROOM

09-25-06 ISSUED FOR CONSTRUCTION
09-14-06 ISSUED FOR PERMIT

HEINTZ & FIORE • LLC	
ARCHITECTS • AIA	
87 woodland road short hills • new jersey • 07078 973-467-1240 fax 973-376-0963	
RESIDENCE FOR Y. BRONSTEIN 120 LAWRENCE DRIVE SHORT HILLS, NEW JERSEY 07078	
drawing title: BASEMENT PLAN	ROBERT B. HEINTZ • AIA architect • NJ - C 4352 planner • NJ - LI 01553 DONALD P. FIORE • AIA architect • NJ - AI 10410
job no.: 2534 date: 8/25/06	scale: AS NOTED drawn by: SAS